



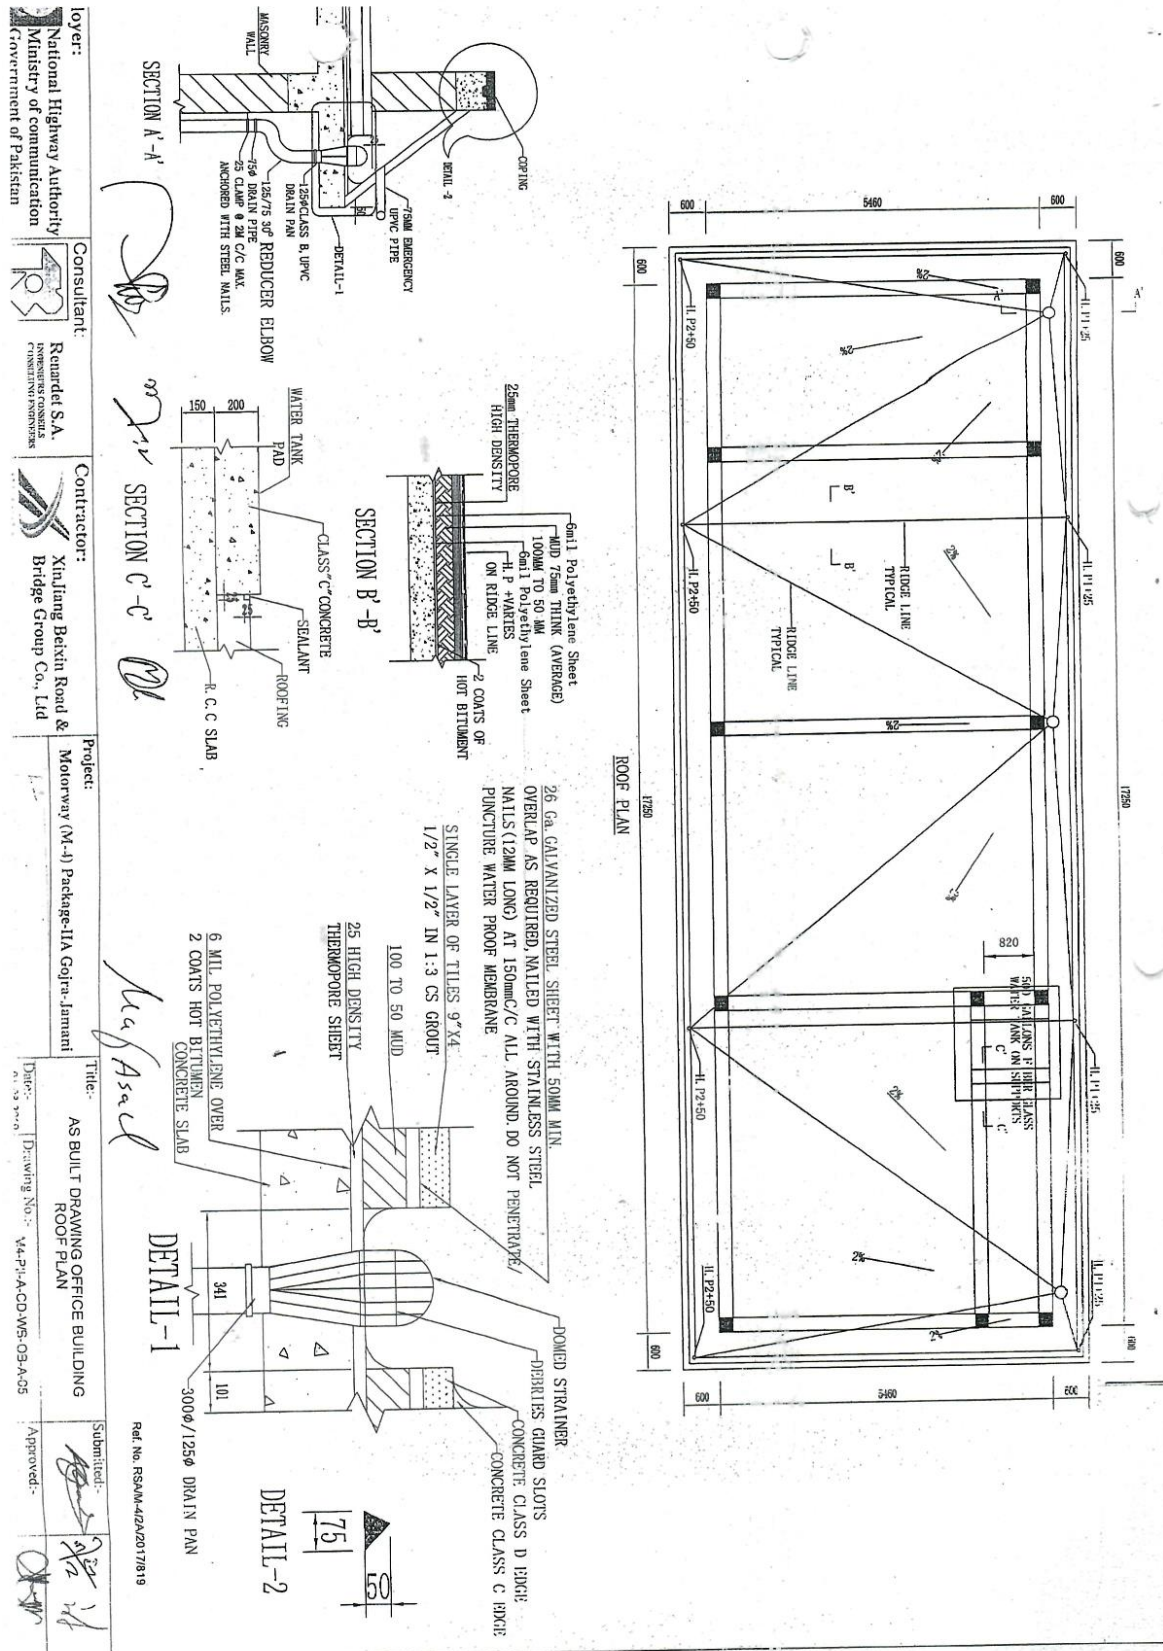

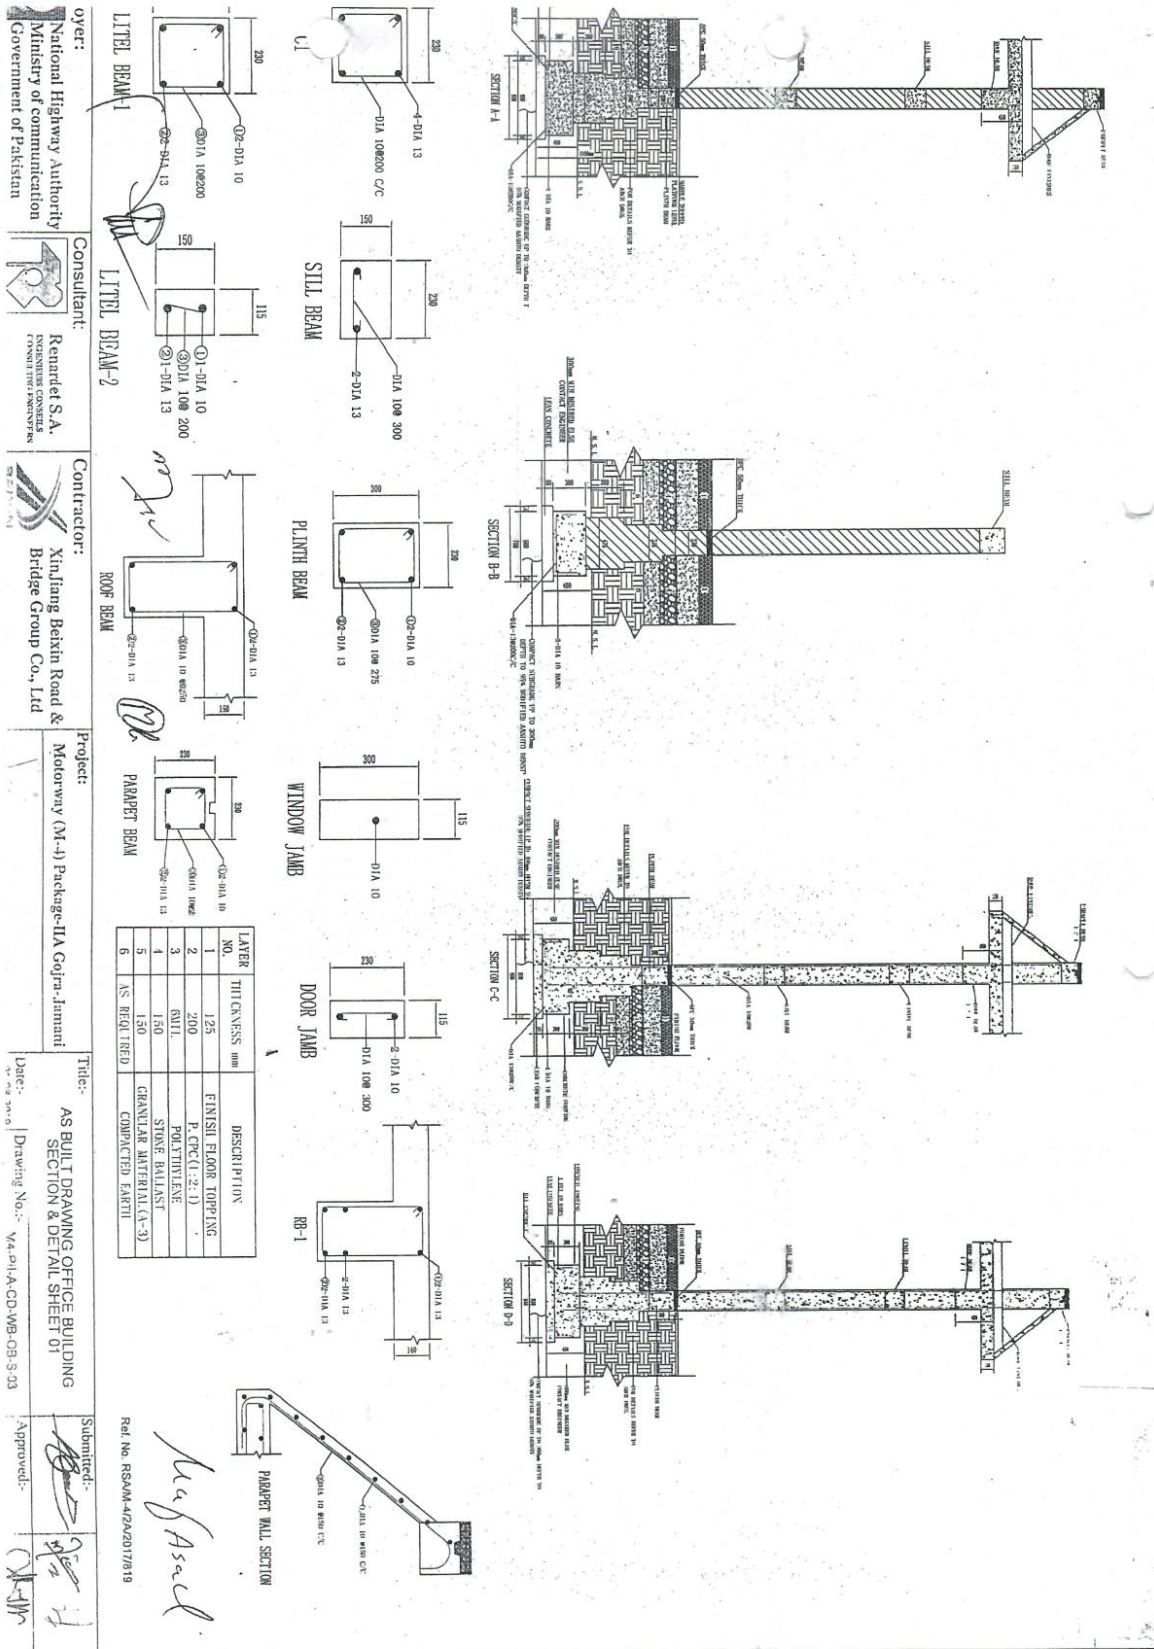


Client:	National Highway Authority Ministry of Communication Government of Pakistan	Consultant:	Renardet S.A. INGENIEROS CONSULTORES CONSTRUCTORES	Contractor:	Xinjiang Baixin Road & Bridge Group Co., Ltd	Project:	Motorway (M-4) Package-IIA Gajra-Jamali	Title:	AS BUILT DRAWING OF OFFICE BUILDING SECTION & DETAIL SHEET 02	Submitted:	12/12/2017
Drawn:	1/2/2017	Approved:	12/12/2017	Checked:	12/12/2017	Reviewed:	12/12/2017	Final:	12/12/2017	Signature:	12/12/2017

LAYER NO.	THICKNESS mm	DESCRIPTION
1	125	FINISH FLOOR TOPPING
2	200	P.CPC (1:2:4)
3	60	POLYETHYLENE
4	150	STONE BALLAST
5	150	GRANULAR MATERIAL (A-3)
6	AS REQUIRED	COMPACTED EARTH

NOTES:
1-REFER TO SHEET M4-P-II-AATD-CN-S-01 FOR
GENERAL NOTES, LAP SPLICE AND CLEAR COVER
REQUIREMENTS.

Rd No. RSMM-4/2A/2017/819

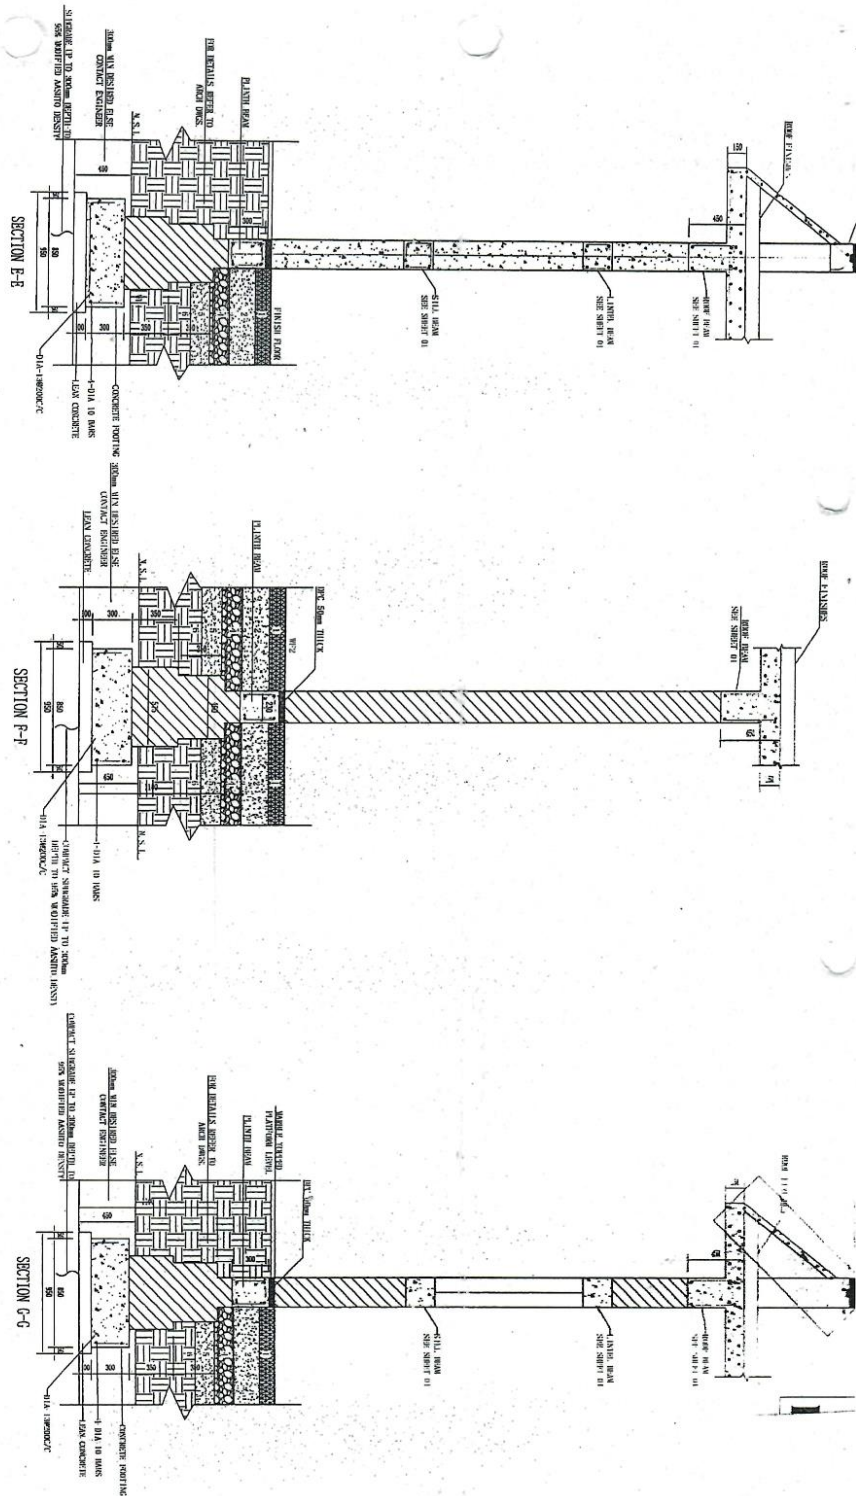



Owner: National Highway Authority Ministry of communication Government of Pakistan	Consultant: Remanet S.A. INGENIERIA Y ARQUITECTURA CONSEJO REGULADOR	Contractor: Xinjiang Beixin Road & Bridge Group Co., Ltd	Project: Motorway (M-4) Package-IIA Gdpr-Jammi	Title: AS BUILT DRAWING OF OFFICE BUILDING LIGHTING & POWER LAYOUT PLAN
--	--	---	--	--

Date: Drawing No: 44-P1-A-CD-MB-08-E-07


Submitted:

Approved:


POWER LAYOUT PLAN OFFICE BUILDING

Ref No RSAM-41242017819

NOTES:
1-REFER TO SHEET M4-P11-AATD-CN-E-FOR
ELECTRICAL NOTES.
2-REFER TO SHEETS M4-P11-AATD-CN-E-01 OR 02
LIGHTING PROTECTION & GROUNDING DETAILS.

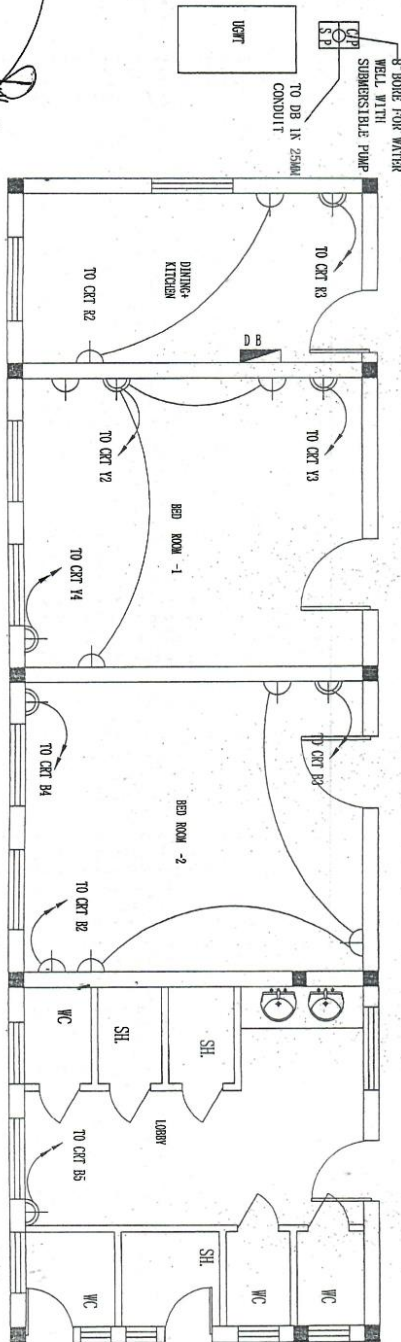

LIGHTING LAYOUT PLAN OFFICE BUILDING

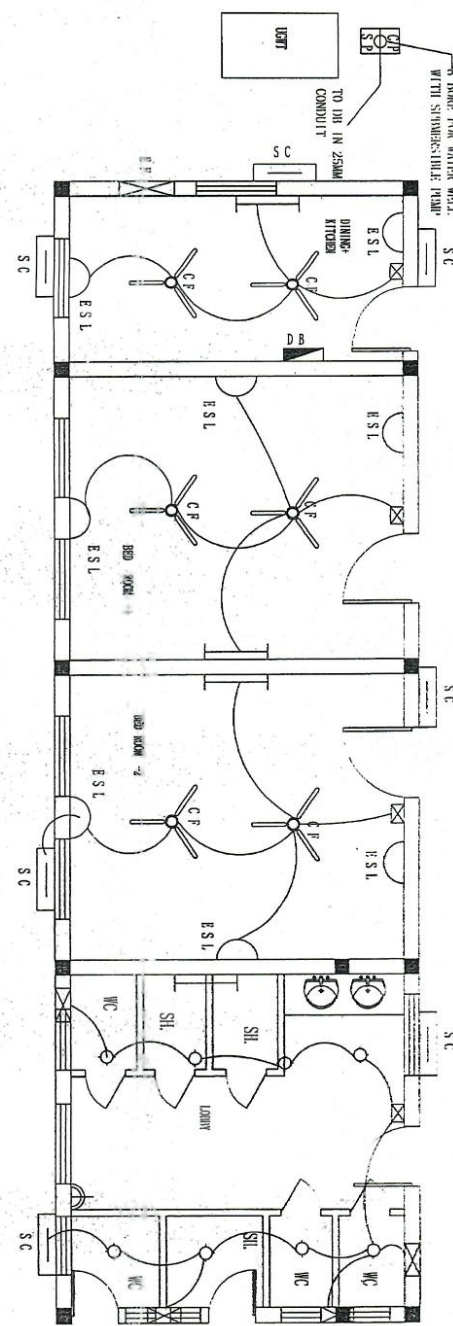

Client:
National Highway Authority
Ministry of Communication
Government of Pakistan

Consultant:
Remarquet S.A.
Consulting Engineers
Rabat, Morocco

Contractor:
Xinjiang Beixin Road &
Bridge Group Co., Ltd

Project:
Motorway (M-4) Package-11A (Gujra-Jamali)


Title:
AS BUILT DRAWING OF OFFICE BUILDING
DB DETAIL

Drawing No.: W4P-ACD-WB-08-E-02


Submitted:
Approved:

Ref No: RSNM/402/2017/819



4 CORE 6mm² PVC/PVC/CU
Cable+1X4mm² sq as EOC
FROM MDB in 40mm Conduit

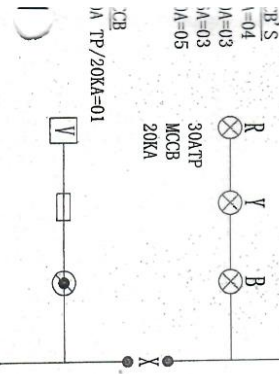

DB NO	1	2	3	4	5	6	7	8	9	10	11	12	13	14	15	16	17	18	19	20
RATING (A)	6	10	16	6	20	6	10	16	20	20	6	10	16	20	20	6	10	16	20	20
DESCRIPTION	Linght , Fan-K	Linght Socket-K	Power Socket-K	Spare	Water Pump OverHead	Bed-1 Light	L. Socket Bed 1	Power Socket-Bed 1	Power Socket-Ac 1	Sub-Water Pump	Bed 2 Light. Fan	Light Socket-Bed 2	Light Socket-Bed 2	Power Socket-Ac 2	Power Socket-Toilet					

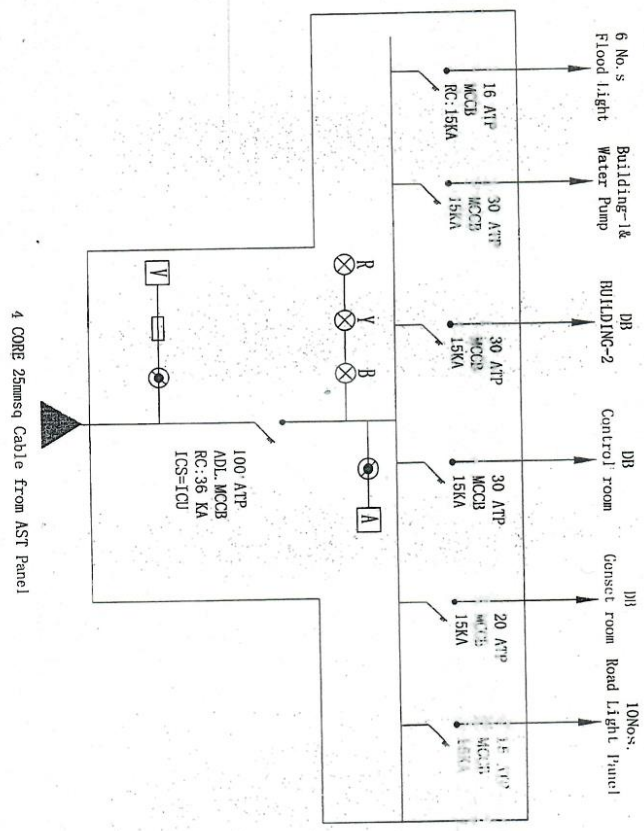

Client: National Highway Authority
 Consultant: Regardel S.A.
 Contractor: Xinjiang Beixin Road & Motorway (M-4) Package IIA Co. Ltd. Jinnani
 Project: AS BUILT DRAWING OF ACCOMMODATION BUILDING
 Title: AS BUILT DRAWING OF ACCOMMODATION BUILDING
 Submitted: 10/12/2021

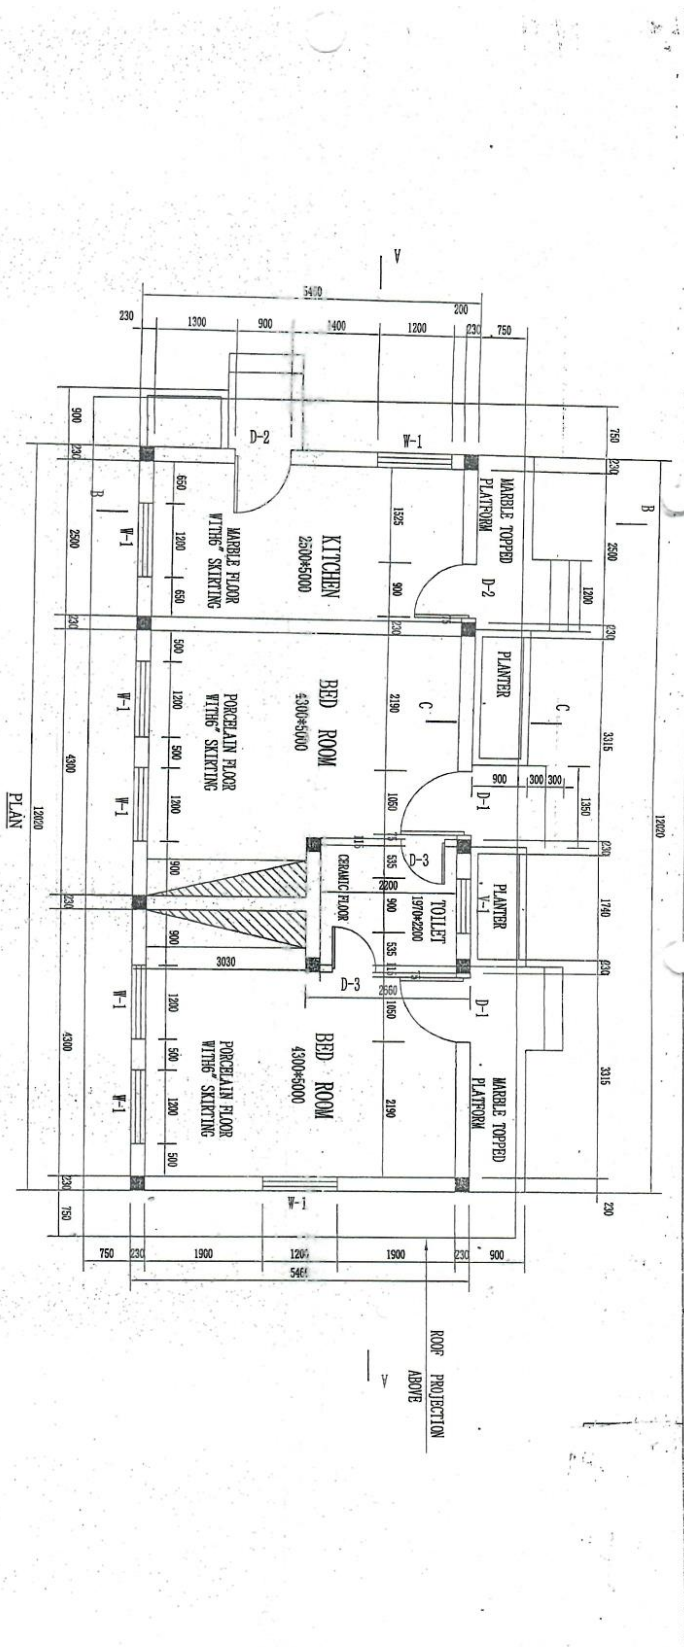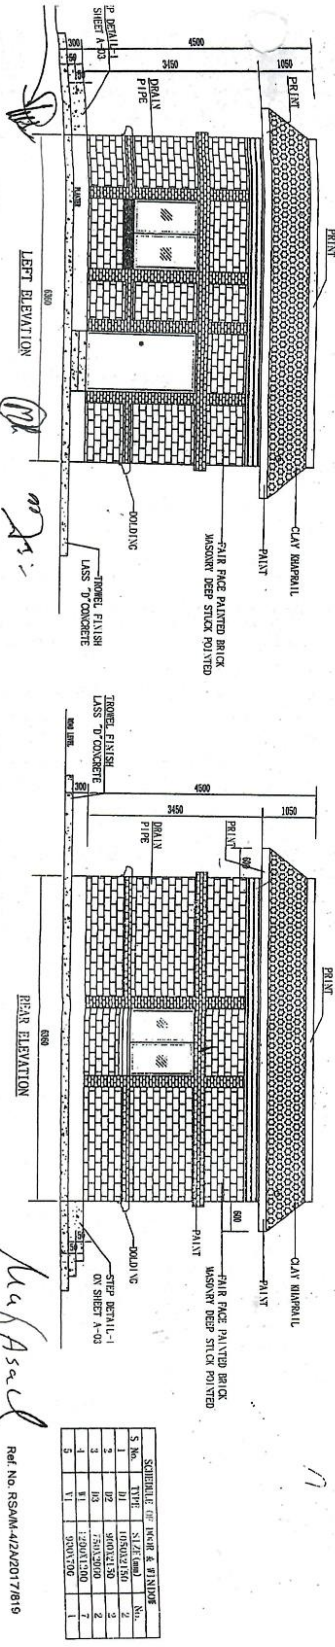

S. No.	ITEM	QTY	UNIT	REMARKS
1	1000x1000	1	Sq. Mtr	Floor Area
2	1000x1000	1	Sq. Mtr	Floor Area
3	1000x1000	1	Sq. Mtr	Floor Area
4	1000x1000	1	Sq. Mtr	Floor Area
5	1000x1000	1	Sq. Mtr	Floor Area
6	1000x1000	1	Sq. Mtr	Floor Area
7	1000x1000	1	Sq. Mtr	Floor Area
8	1000x1000	1	Sq. Mtr	Floor Area
9	1000x1000	1	Sq. Mtr	Floor Area
10	1000x1000	1	Sq. Mtr	Floor Area

Client: National Highway Authority


Consultant: Remarcel S.A.


Contractor: Xinjiang Beixin Road & Motorway (M-4) Package-11A Gofra-Jamani


Project: AS BUILT DRAWING OF ACCOMMODATION BUILDING FRONT & REAR ELEVATION

Ref No. RSAM-12/2017/819

Submitted:-

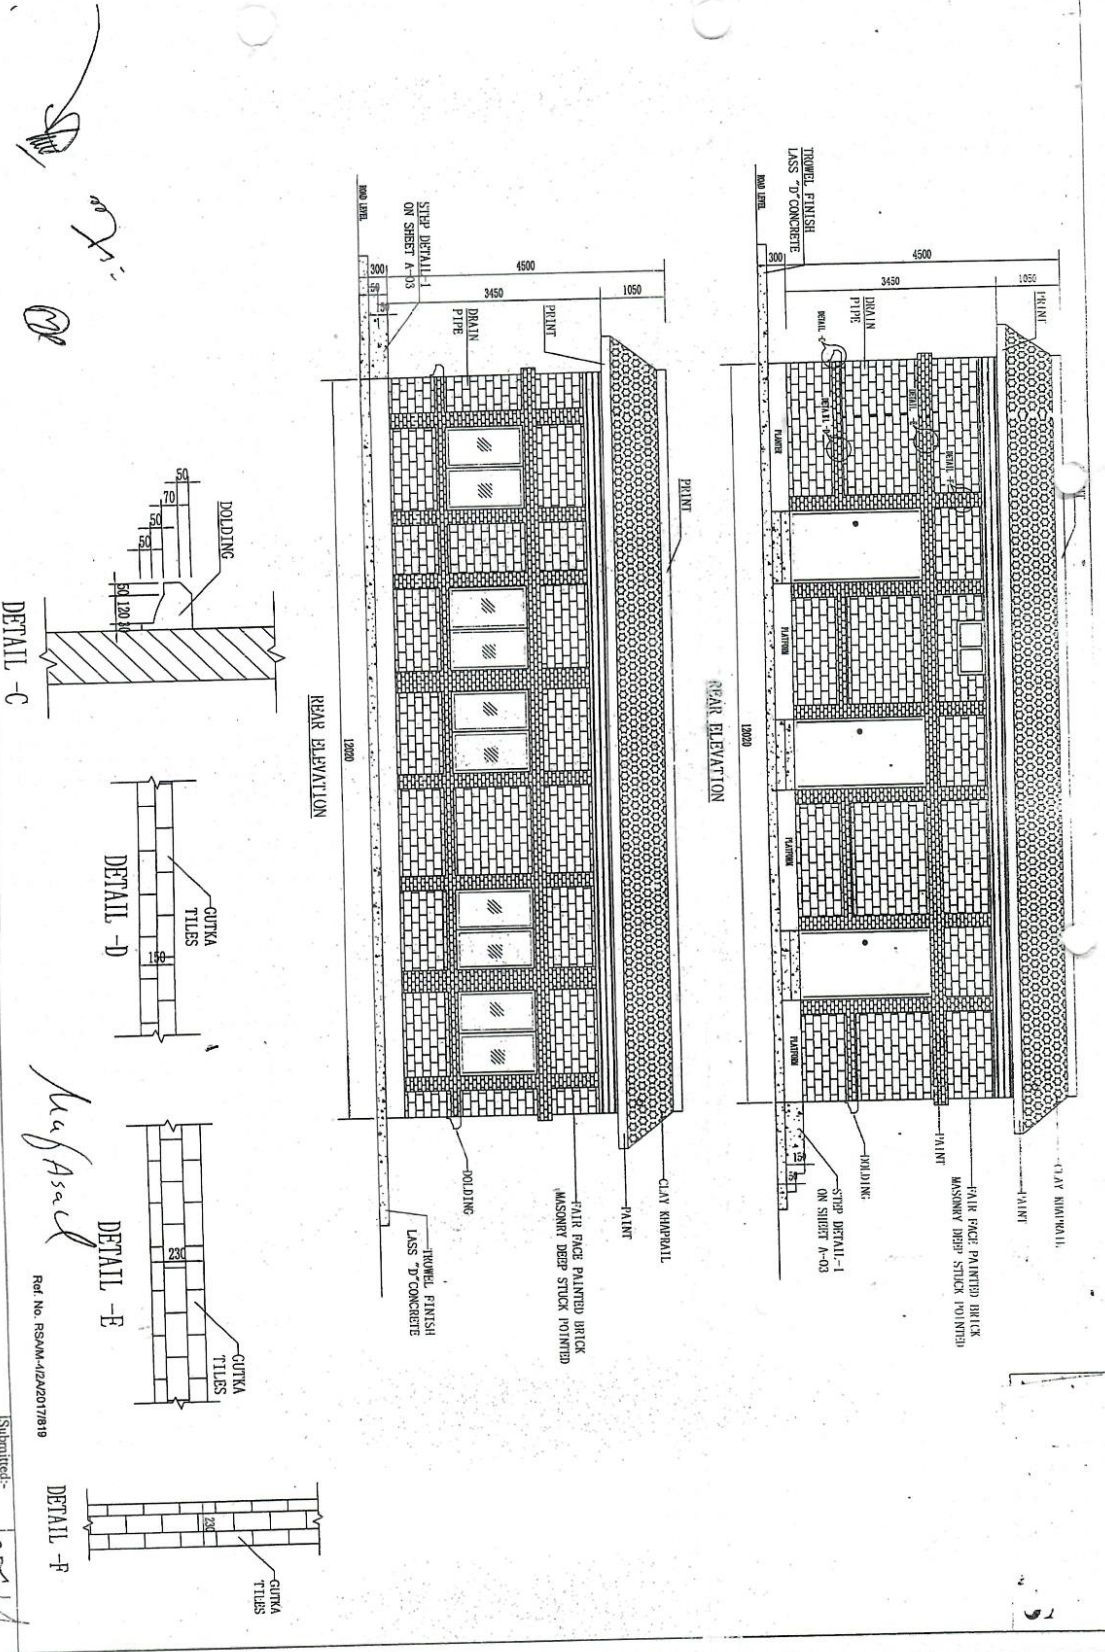

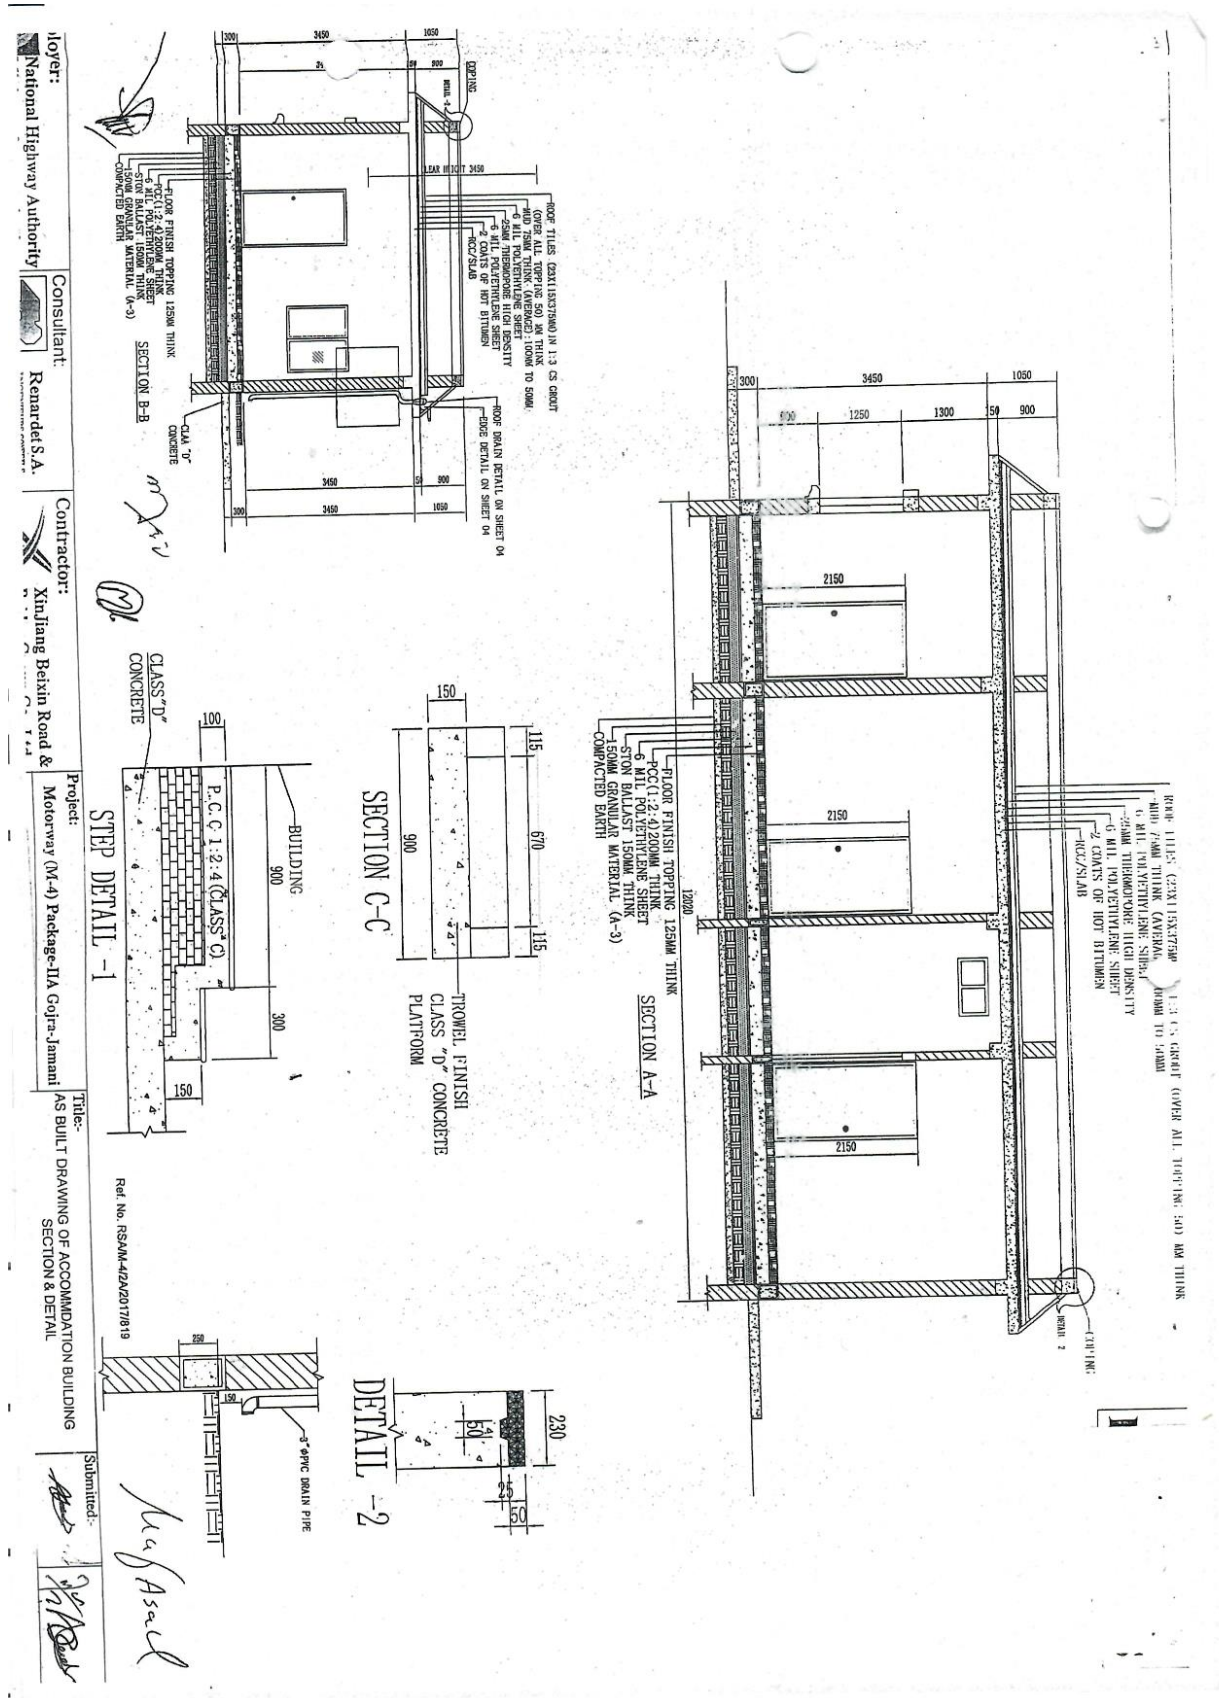


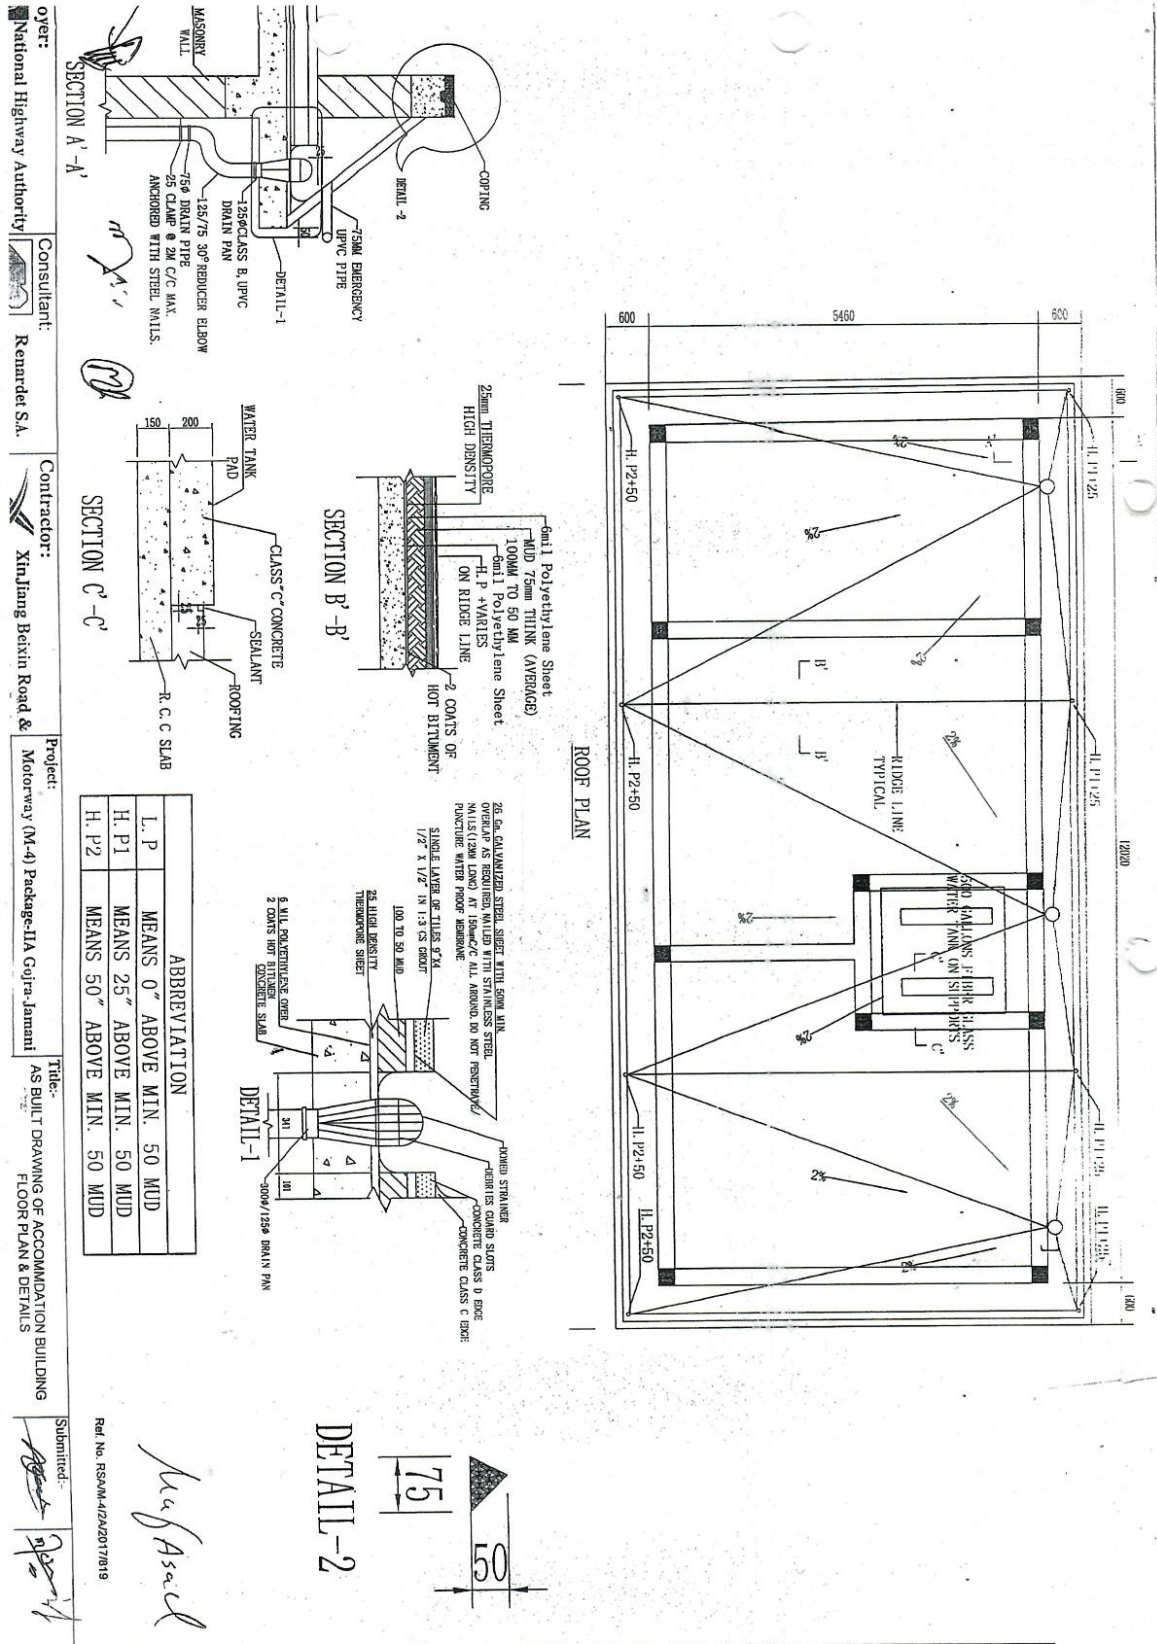

Owner: National Highway Authority
 Consultant: Renardet S.A.
 Contractor: Xinjiang Beixin Road & Motorway (M-4) Package-IIA Gofra-Jamuni
 Title: AS BUILT DRAWING OF ACCOMMODATION BUILDING FOUNDATION PLAN & PLINTH/SILL/LINTEL
 Submitted:

Handwritten signature
Handwritten initials

PLINTH/SILL/LINTEL

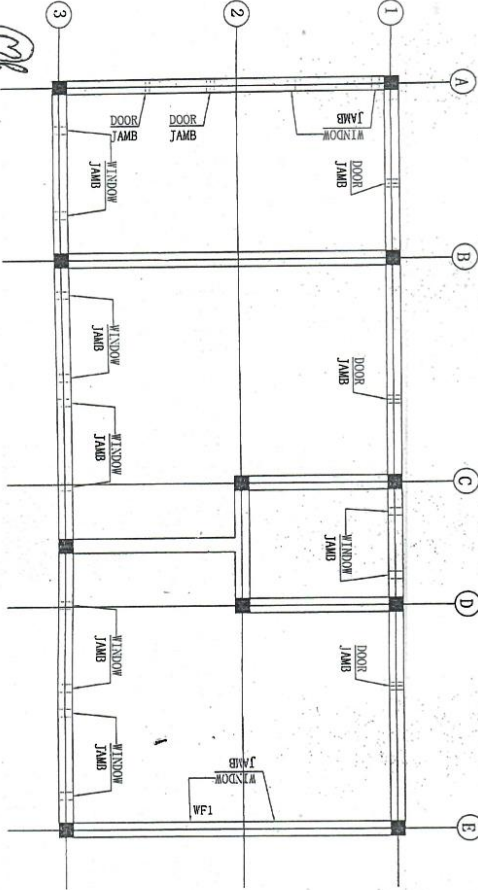



NOTES:
 1- REFER TO SHEET MA-P-II-AAD-CN-5-01 FOR
 GENERAL NOTES, LAP SPICE AND CLEAR COVER
 REQUIREMENTS.

Handwritten signature

Ref. No. RSM/42A/2017/619

FOUNDATION PLAN

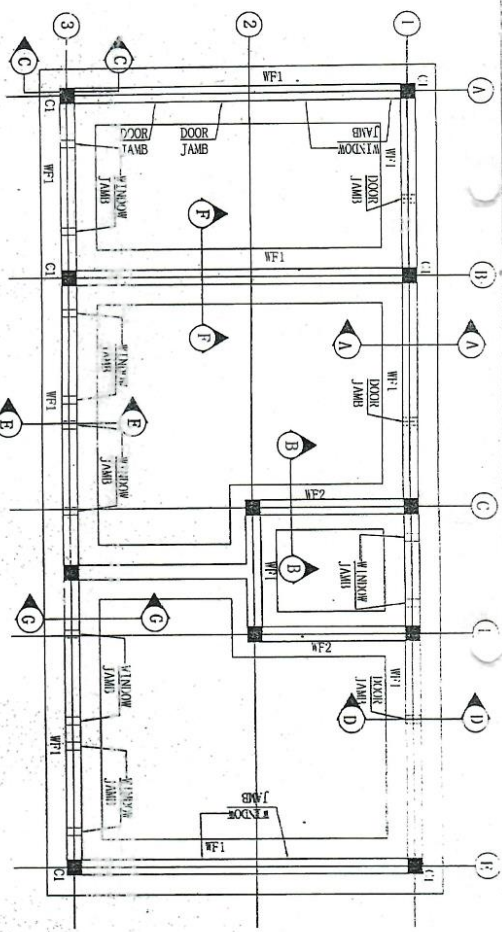

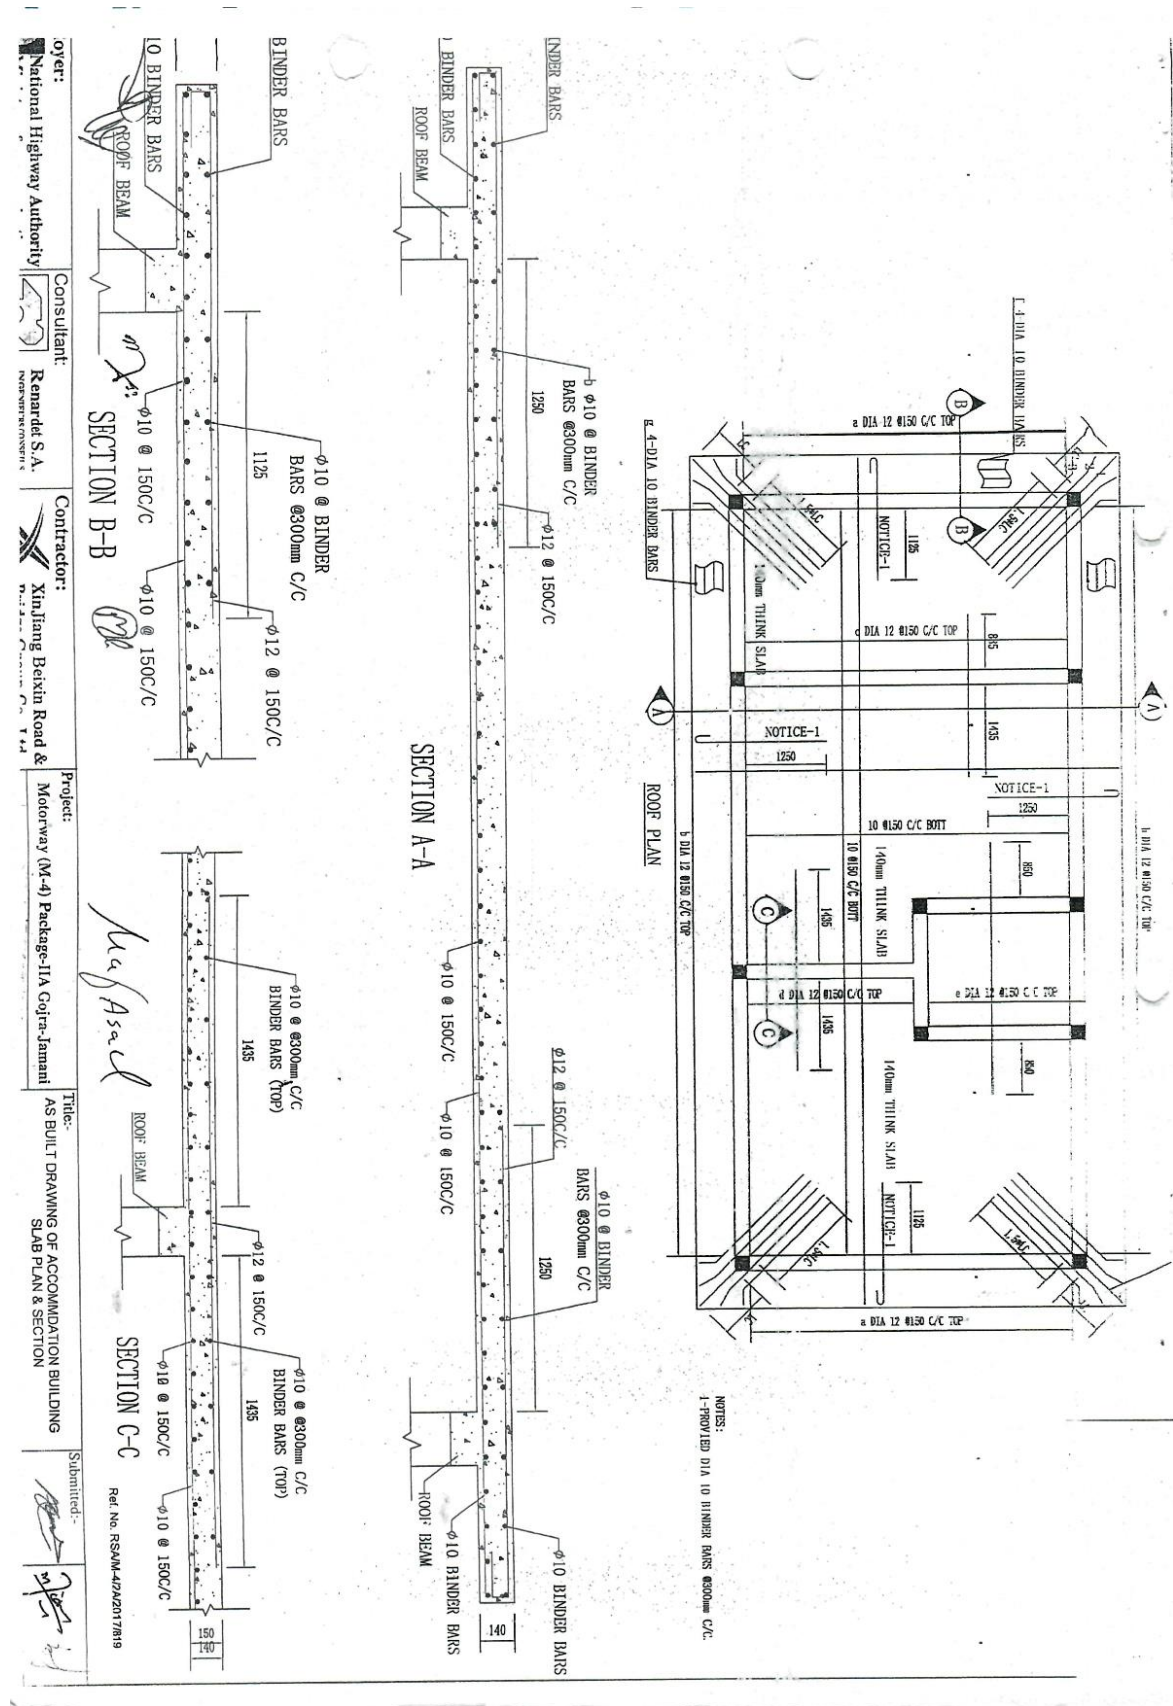

Client: National Highway Authority
 Consultant: Remarcel S.A.
 Contractor: Xinjiang Beixin Road & Motorway (M-4) Package-IIA Gofra-Jamani
 Title: AS BUILT DRAWING OF ACCOMMODATION BUILDING SECTION SHEET 01
 Submitted: [Signature]

